

SPRINKLER RISER

NOT TO SCALE

CITY OF RALEIGH FIRE DEPARTMENT
 FIRE PROTECTION DIVISION
 310 WEST MARTIN ST. RALEIGH, NC 27602


DESCRIPTION:
 SPRINKLER RISER DETAIL (DRY)

REVISIONS:
 5-1-06
 W Warren u

DATE:

DRAWING NO.
 FP-4A

THRUST BLOCK
 DETAIL W-7

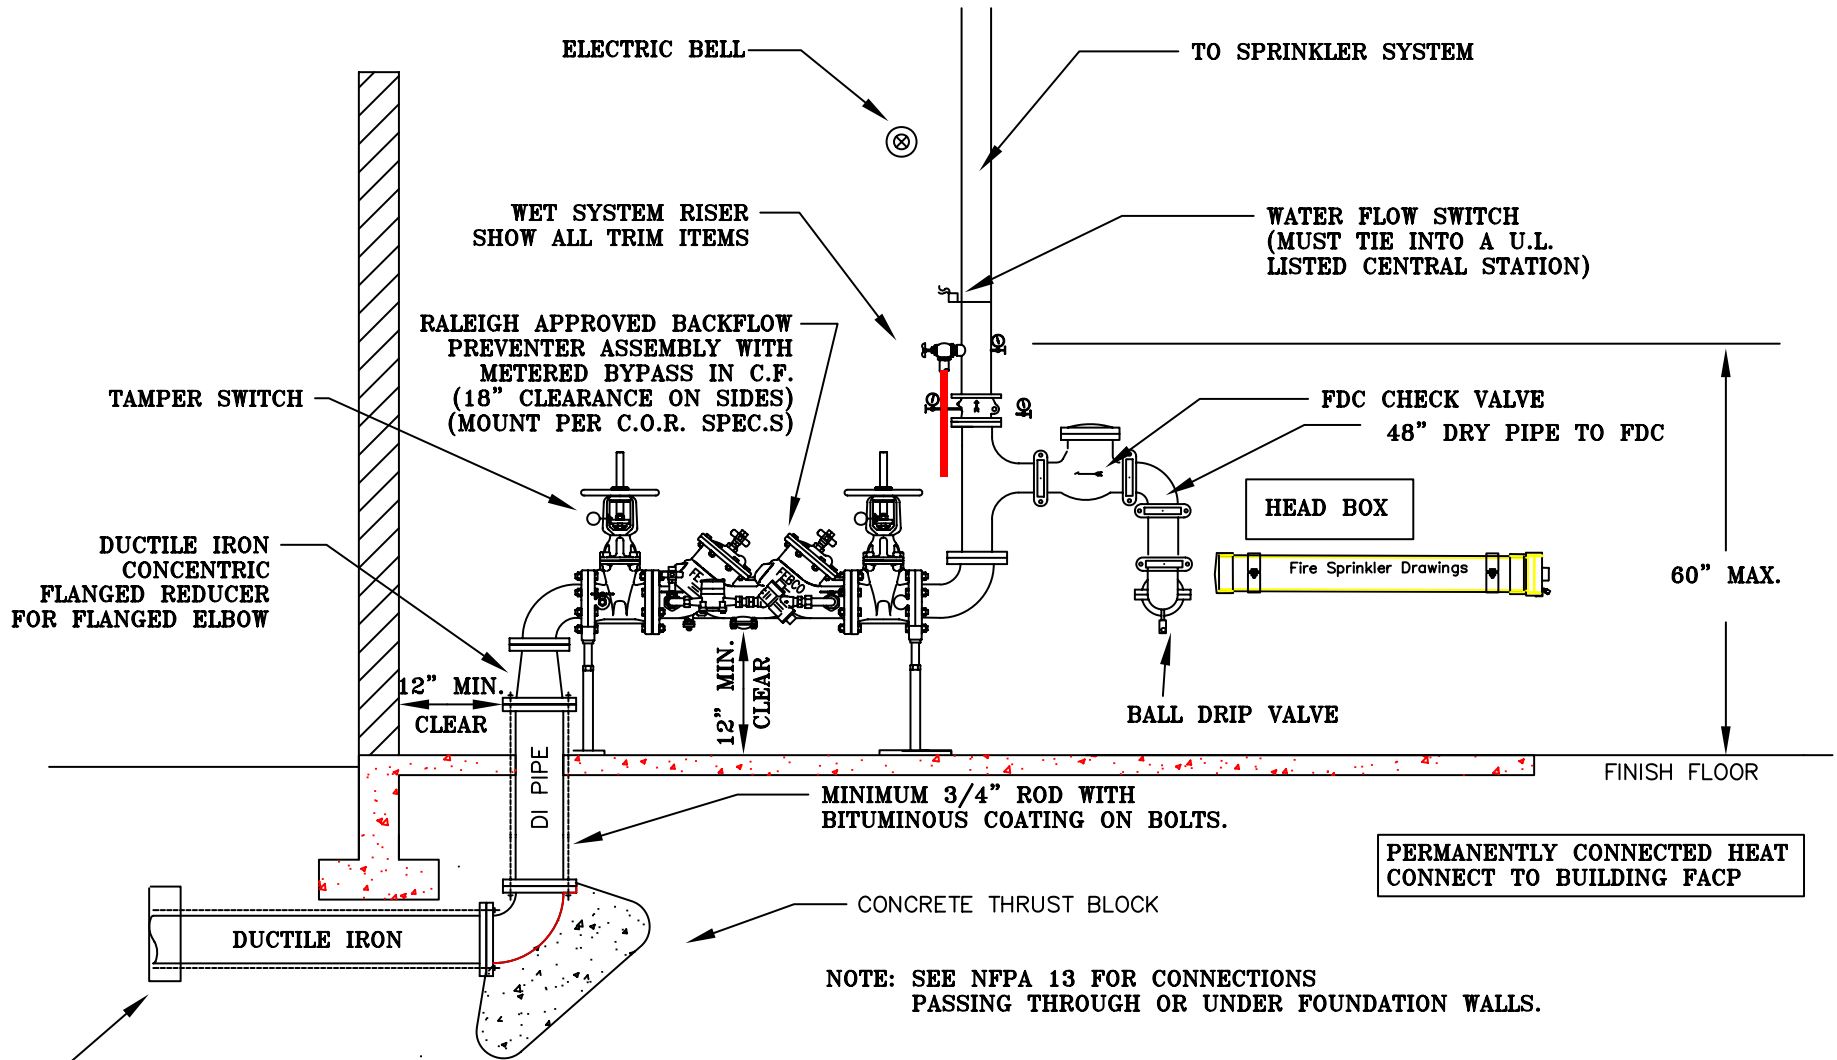

SPRINKLER RISER

NOT TO SCALE

CITY OF RALEIGH FIRE DEPARTMENT
FIRE PROTECTION DIVISION
310 WEST MARTIN ST. RALEIGH, NC 27602

DESCRIPTION:
SPRINKLER RISER DETAIL (WET)

REVISIONS:
5-1-06
W Warren u

DATE:

DRAWING NO.
FP-4B